





 

 
 










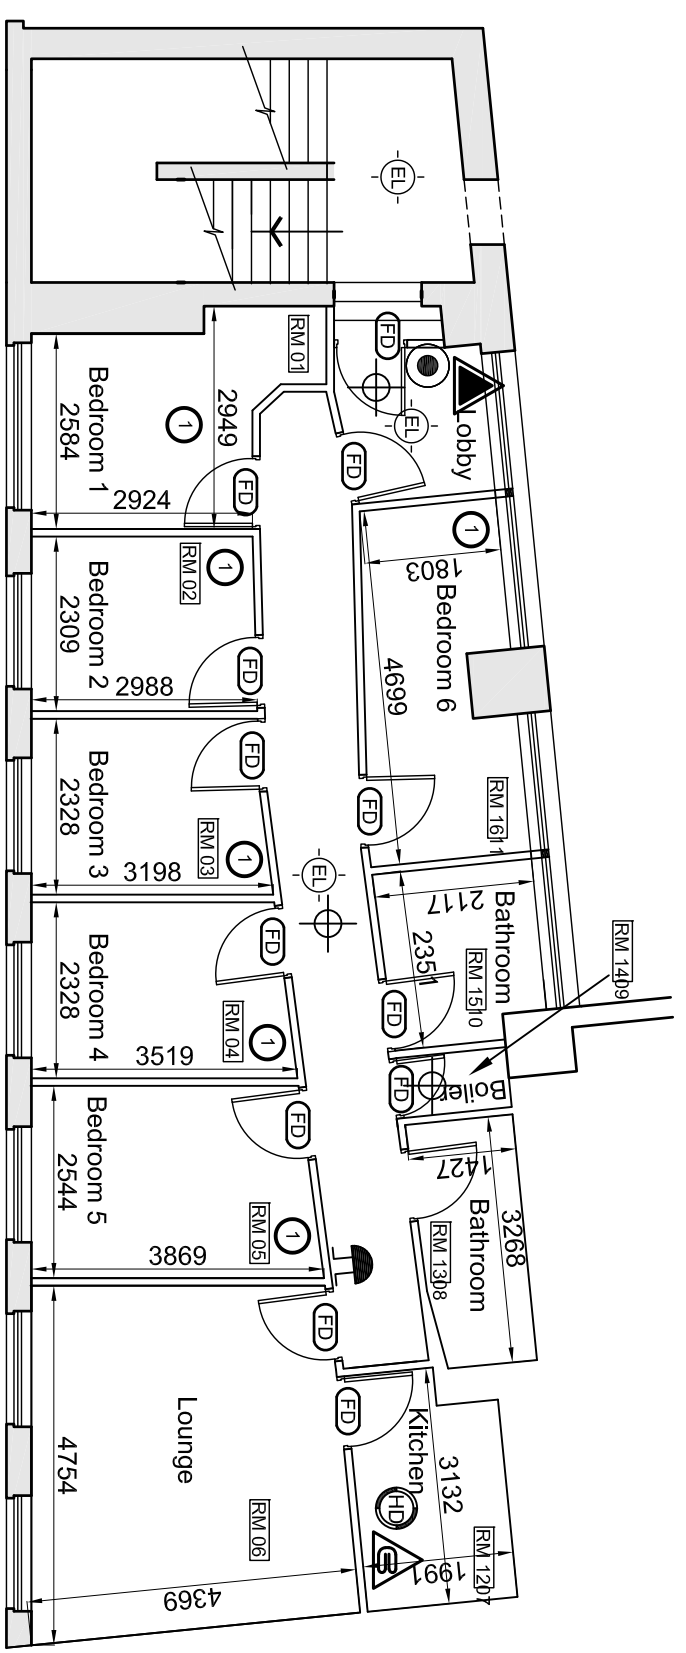


- Legend**
-  Fire Escape Route
 -  Fire Door
 -  Vision Panel
 -  Compartmentation
 -  Emergency Exit
 -  Emergency Lighting
 -  Smoke Detector
 -  Break glass unit
 -  Sounder
 -  Flashing Beacon
 -  Heat Detector

Fire Fighting Equipment

-  Hydraulic hose reel (No indicates hose length)
-  Carbon Dioxide fire extinguisher (or Halon)
-  Water fire Extinguisher
-  Dry Powder Extinguisher
-  Foam Fire Extinguisher
-  Aqueous Film Forming Foam Extinguisher
-  Fire Blanket in Container
-  Sand Bucket

- Misc**
-  No of Occupants



Existing Third Floor Plan

PROJECT 5 St Peters Place

SCALE 1:100@A3

DRAWING NUMBER LS/40/L01